


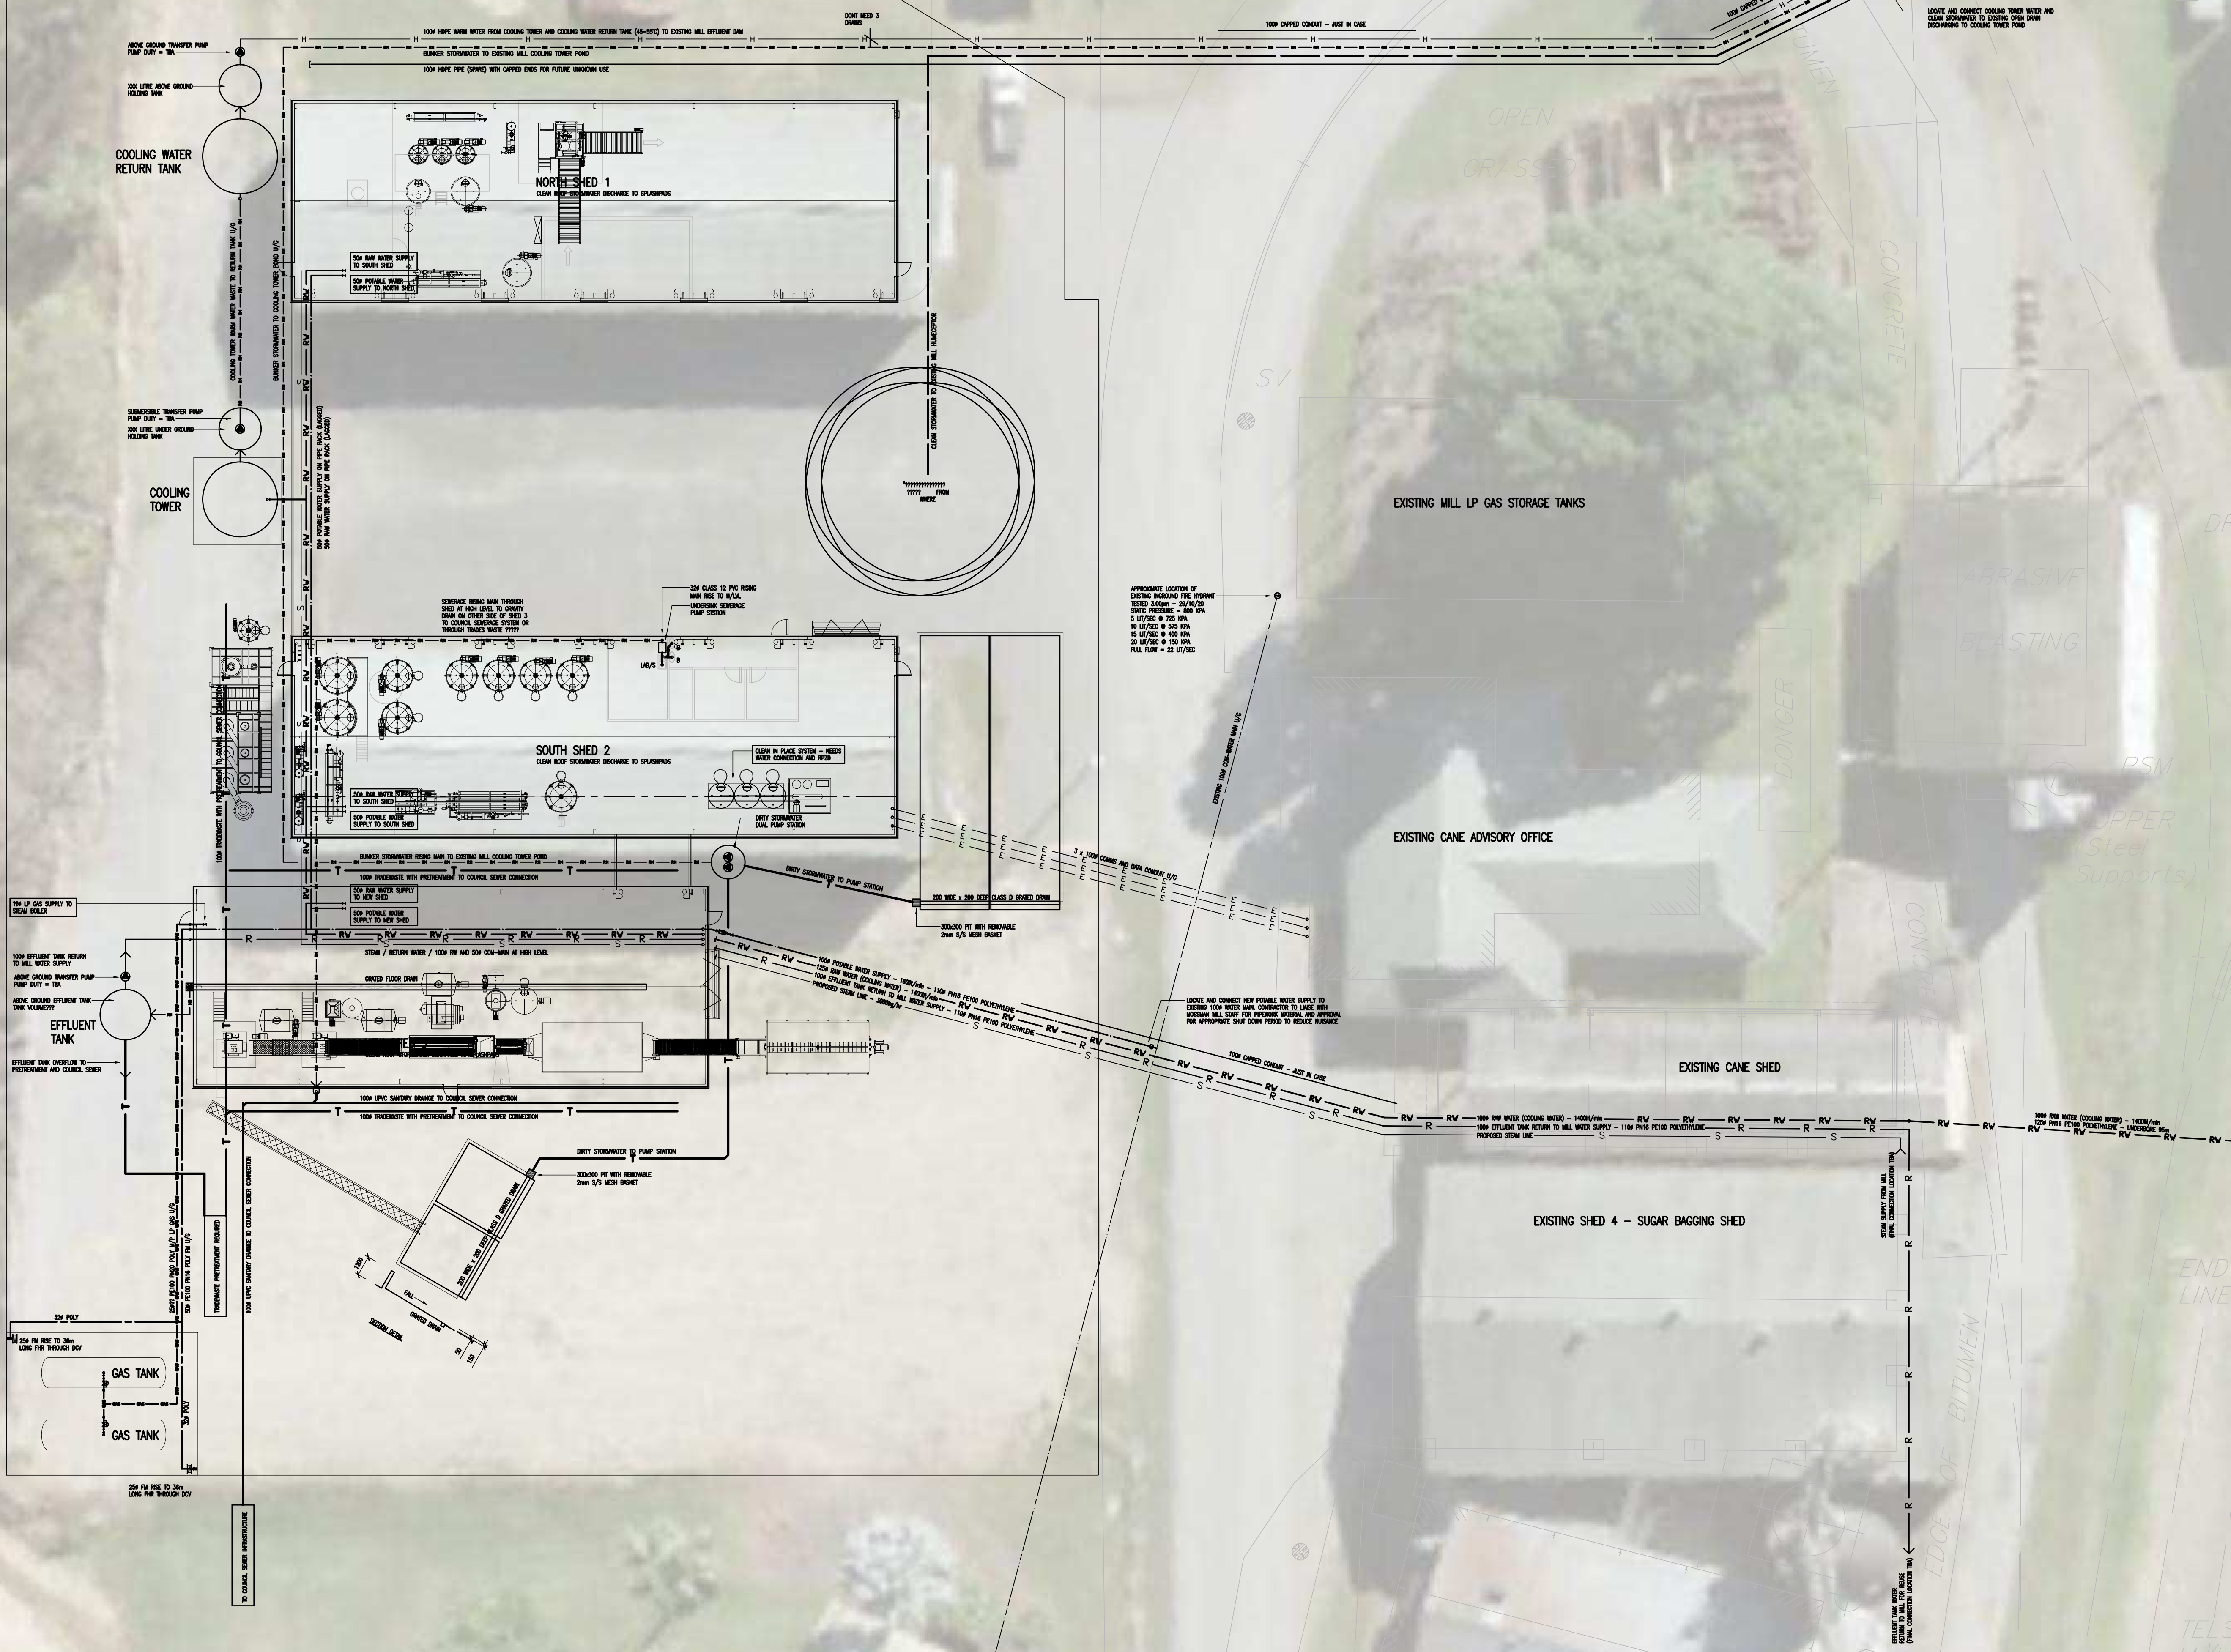

P2	CLIENT REVIEW AND COMMENT	22/03/21
P1	PRELIMINARY ISSUE	15/01/21
ISSUE	SUBJECT	DATE

AMENDMENTS

PROJECT

SOY SAUCE PRODUCTION FACILITY, MILL ROAD, MOSSMAN, QUEENSLAND

ARCHITECT

HYDRAULIC CONSULTANTS

GILBOY HYDRAULIC SOLUTIONS

BUILDING HYDRAULIC SERVICES DESIGN / AIN 85 105 215 432
4/131 SCOTT STREET, BUNGALOW
P.O. BOX 857N, NORTH CAIRNS.
PHONE - (07) 4051 5116
FAX - (07) 4051 5016
EMAIL - greg@gilboy.com.au

0 1 2 3 4 5 6 7

BAR SCALE: - CHECK DRAWING PLOT SIZE FOR ACCURACY

CLIENT

COCONUTZ AUSTRALIA PL

TITLE

HYDRAULIC SERVICES PART SITE PLAN 1of2

DESIGNED	GJG	DRAWN	GJG	CHECKED	KKV
SCALE	1:200 @ A1	DATE	DEC 2020		
JOB No./DWG. No./ISSUE	204123/HS101/P2				

